



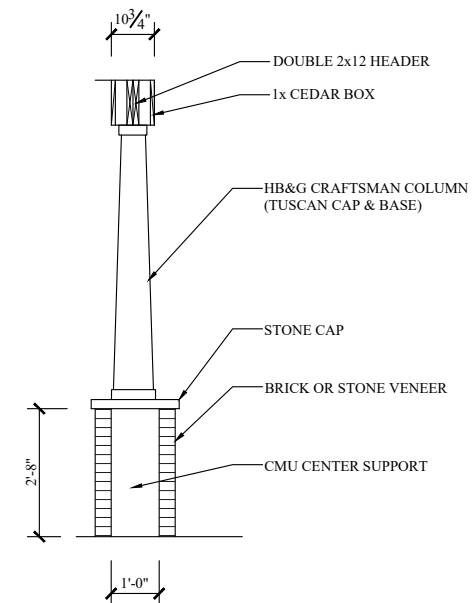


PORCH COLUMN & HEADER SECTION

SCALE: 1/4" = 1'-0"

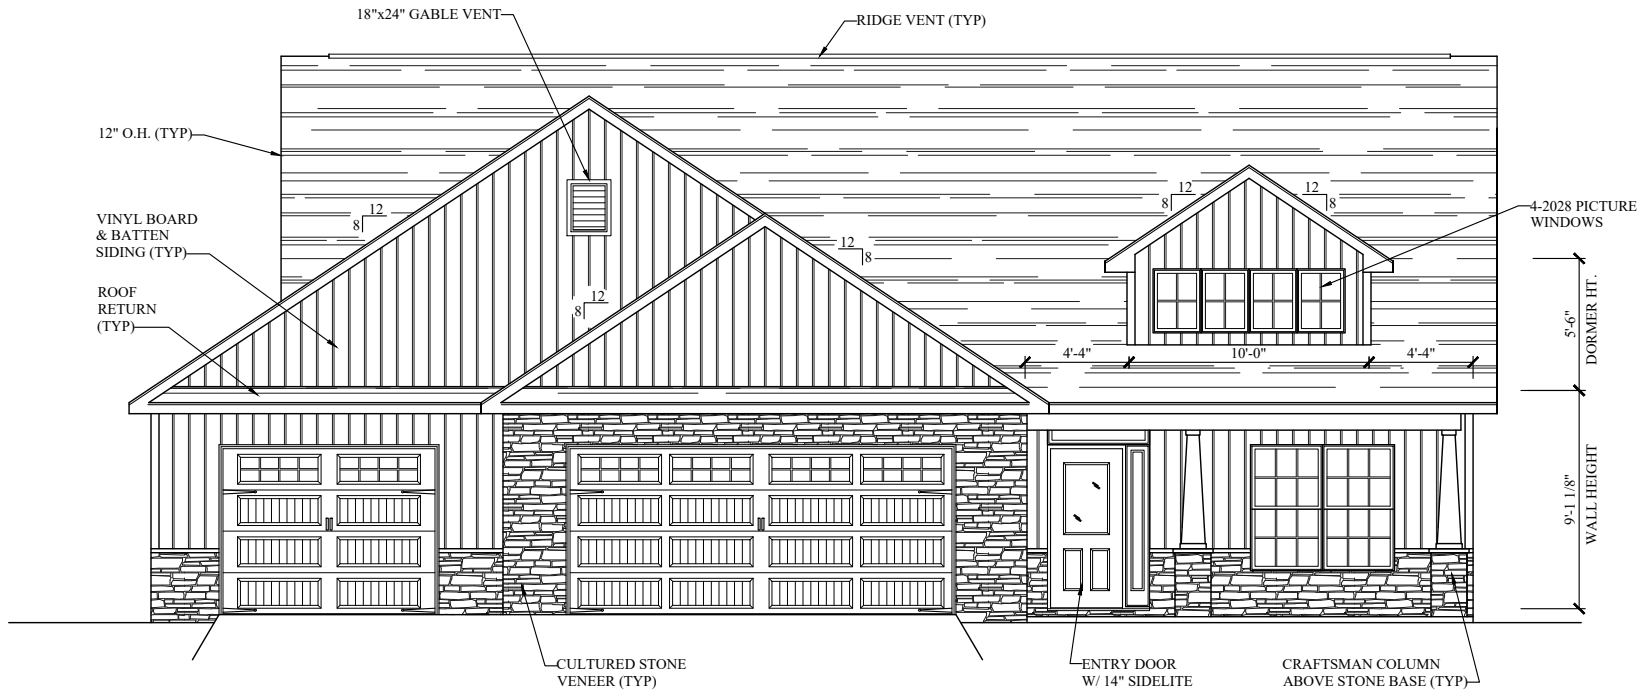


FRONT ELEVATION

SCALE: 1/8" = 1'-0"

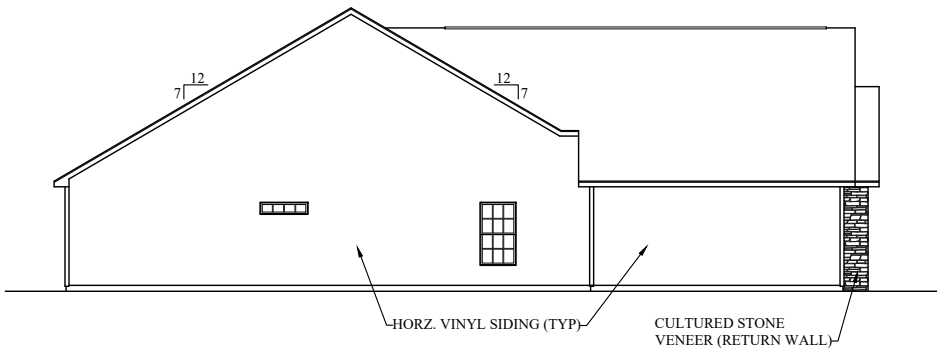


LEFT ELEVATION

SCALE: 1/16" = 1'-0"

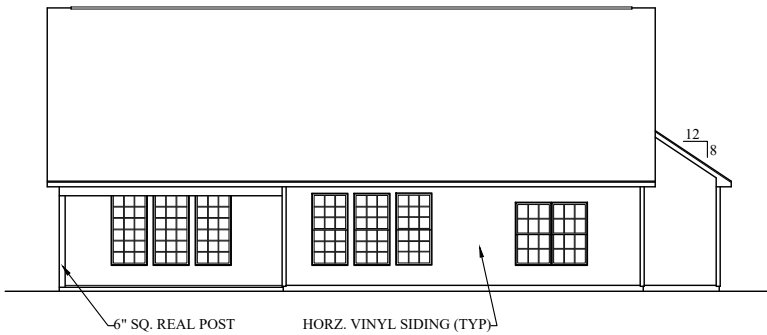

REAR ELEVATION

SCALE: 1/16" = 1'-0"

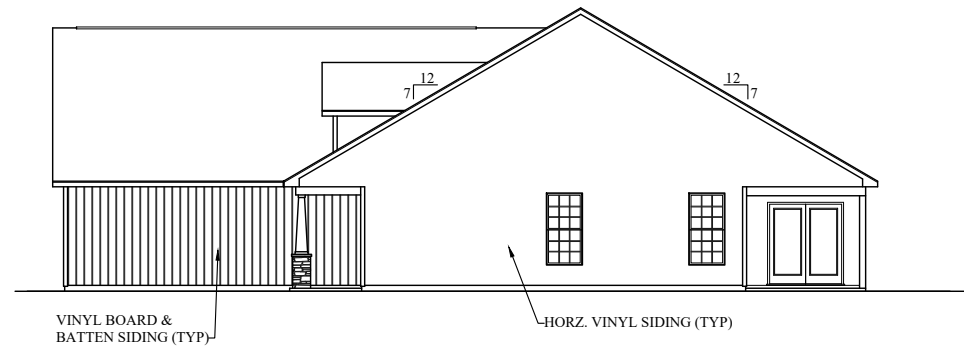


RIGHT ELEVATION

SCALE: 1/16" = 1'-0"

NOTES:

1. 12" ROOF OVERHANG (UNLESS OTHERWISE NOTED.)
2. ALL WALLS TO BE 2x4 (UNLESS OTHERWISE NOTED.)
3. "SIMONTON" SINGLE-HUNG WINDOWS (UNLESS OTHERWISE NOTED.)

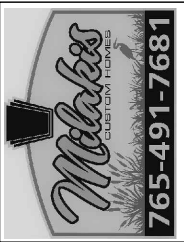

SQUARE FOOTAGE

LIVING: 1857 SF

GARAGE: 871 SF

BLUEPRINT APPROVED

Milakis Rep: _____

Homeowner: _____

Date: _____

Any revisions made after blueprint approval will incur a minimum charge of \$300 in addition to the incurred cost of the physical changes to house.

ELEVATIONS The SEDONA


DATE: 12/13/24

REVISION:

INFO:

1

SHEET

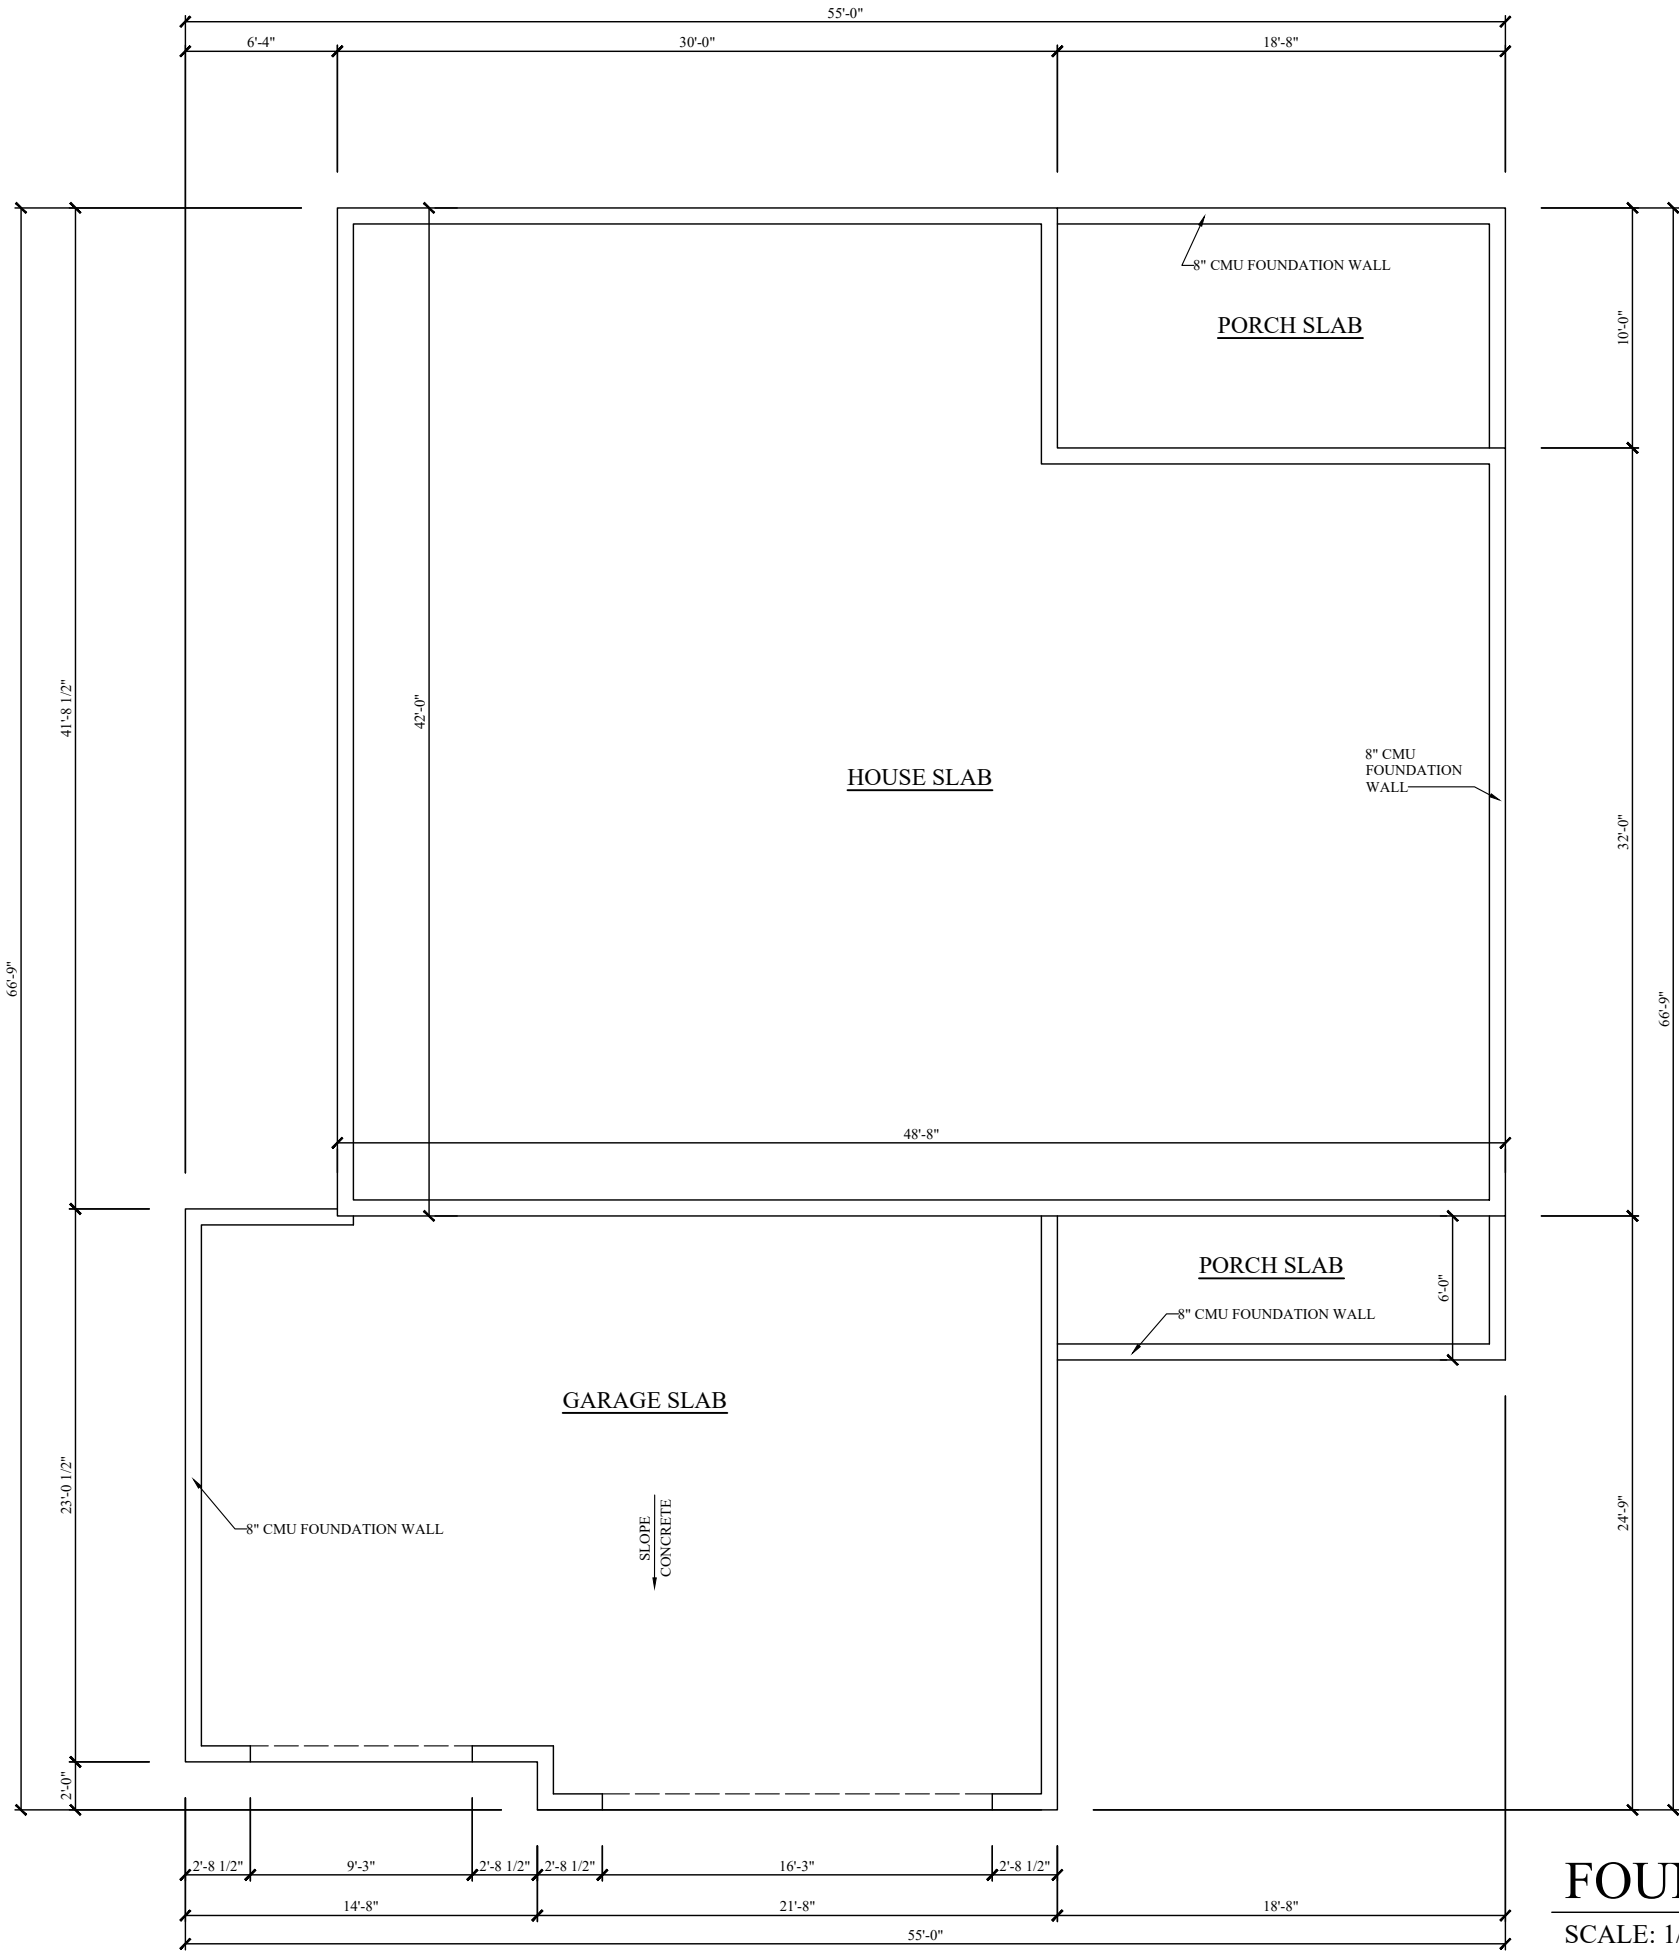

FOUNDATION PLAN

SCALE: 1/8" = 1'-0"




SQUARE FOOTAGE	
LIVING:	1857 SF
GARAGE:	871 SF

BLUEPRINT APPROVED	
Milakis Rep: _____	Homeowner: _____
Date: _____	Any revisions made after blueprint approval will incur a minimum charge of \$300 in addition to the incurred cost of the physical changes to house.


FOUNDATION PLAN
The SEDONA

DATE: 12/13/24
REVISION:
INFO:

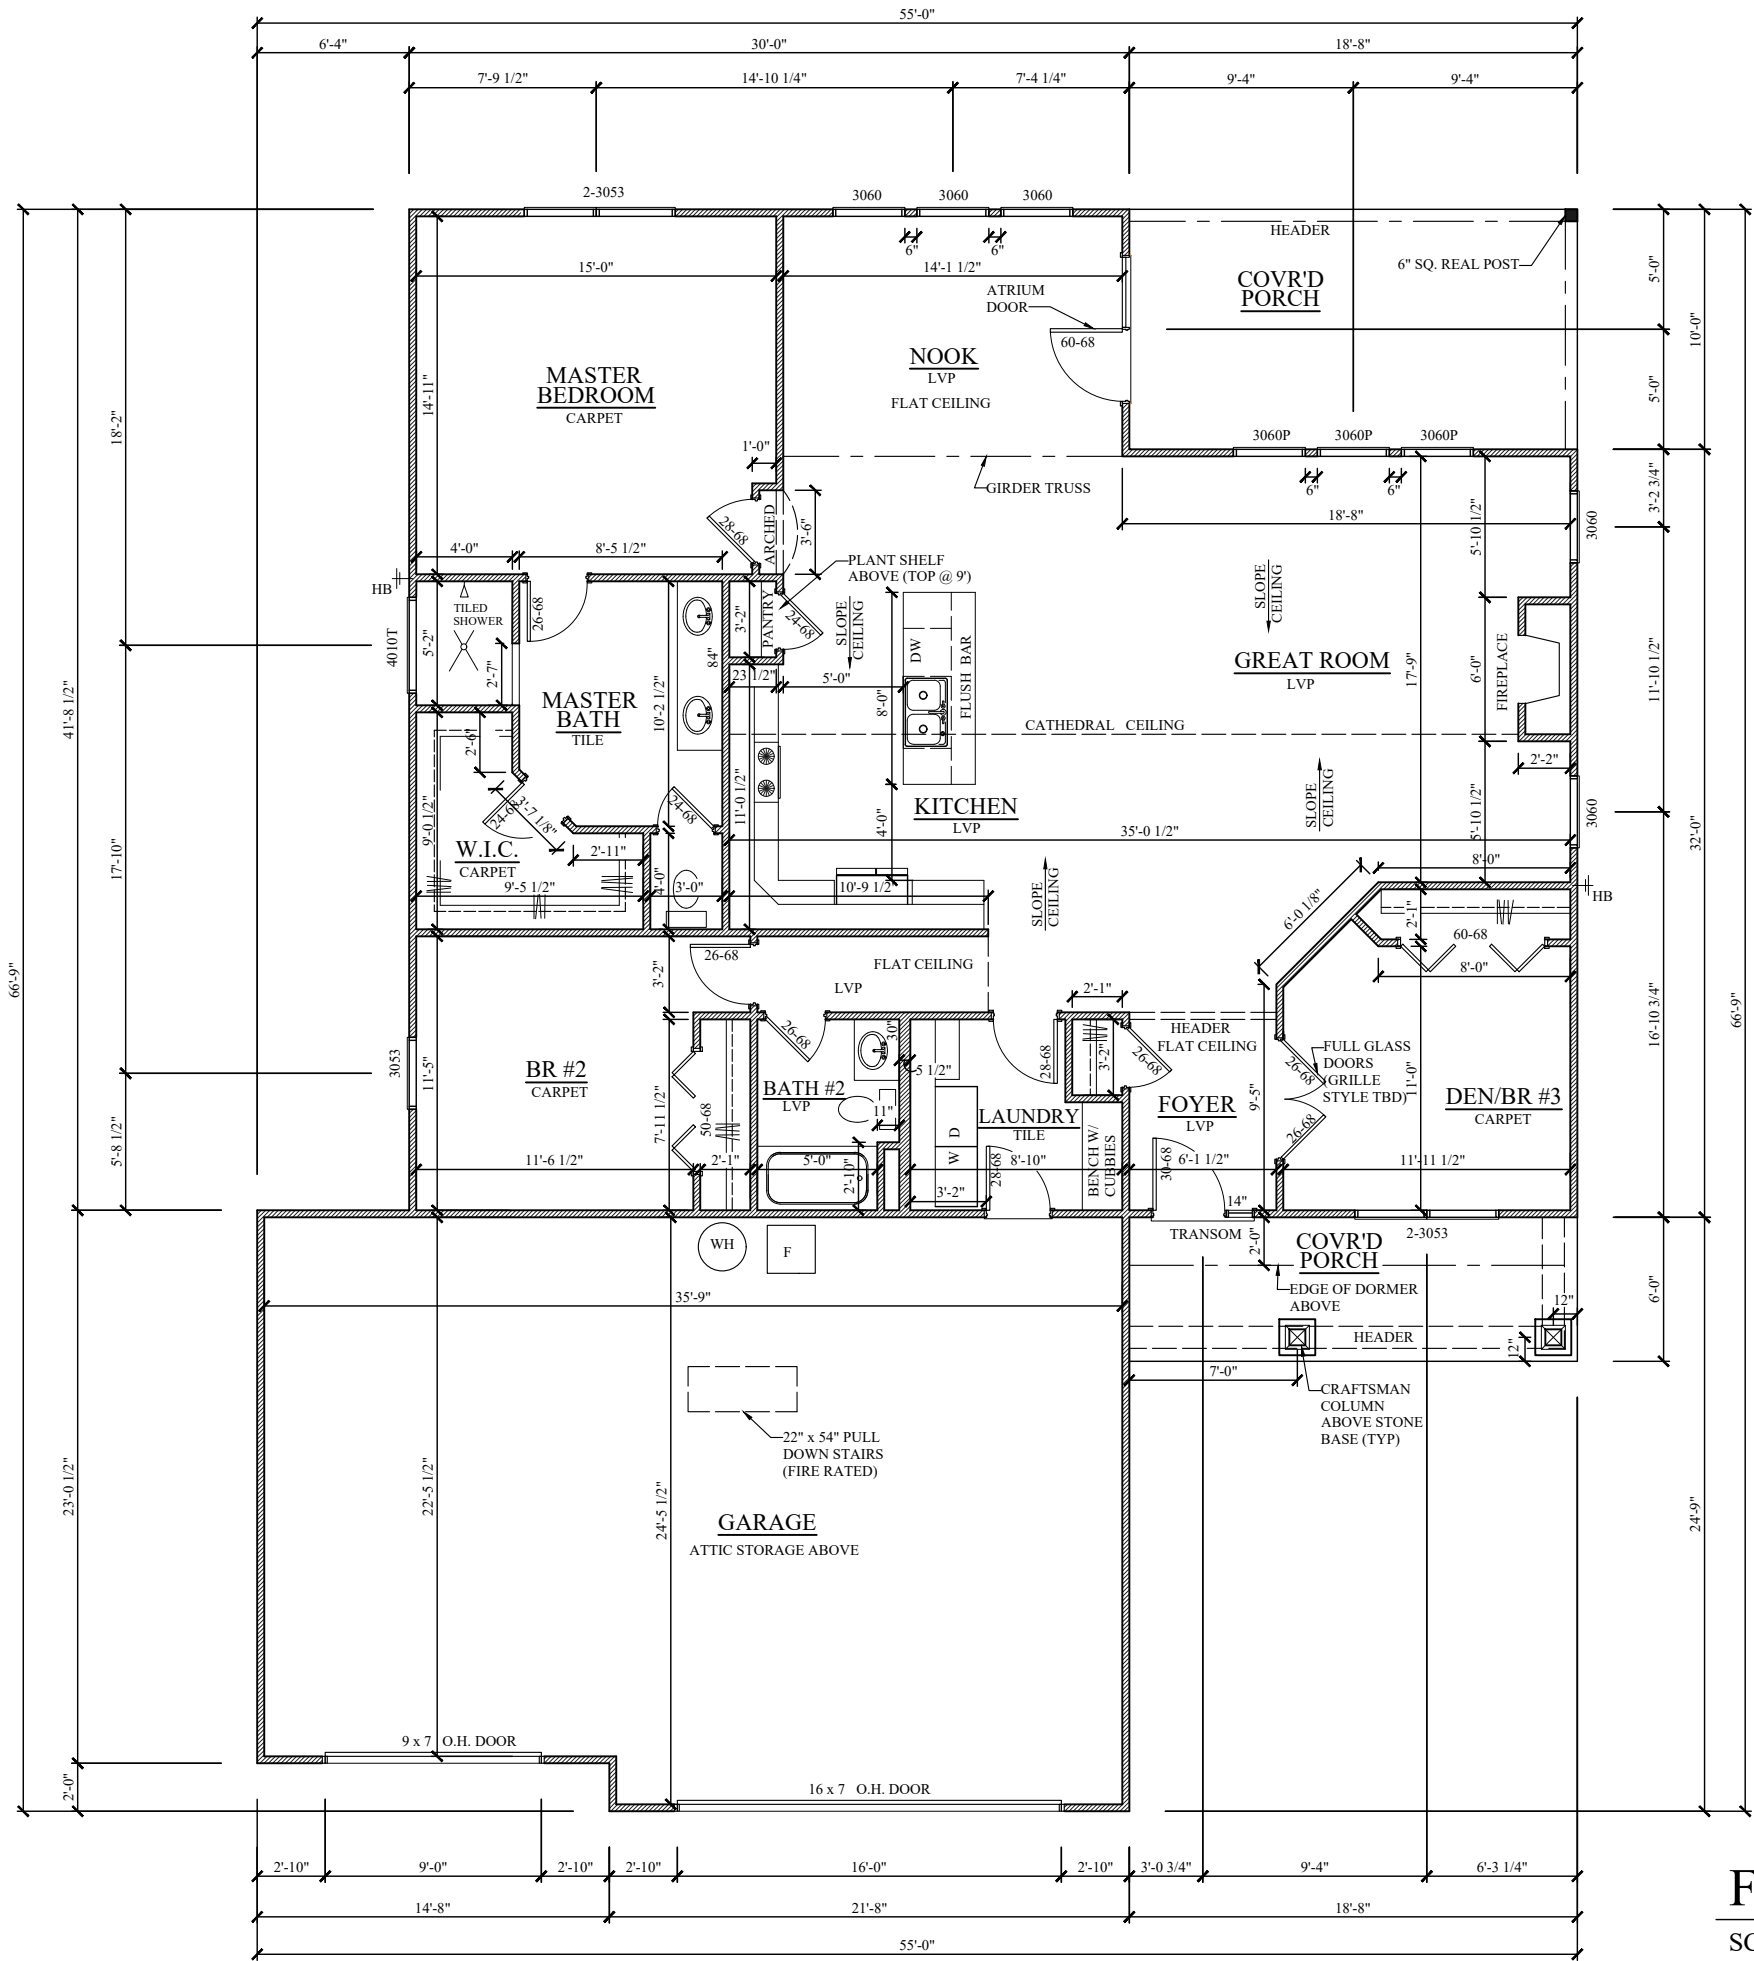

FLOOR PLAN

SCALE: 1/8" = 1'-0"

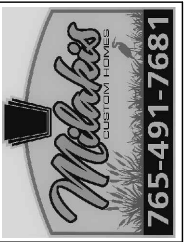


SQUARE FOOTAGE	
LIVING:	1857 SF
GARAGE:	871 SF

BLUEPRINT APPROVED	
Milakis Rep:	
Homeowner:	
Date:	
Any revisions made after blueprint approval will incur a minimum charge of \$300 in addition to the incurred cost of the physical changes to house.	

FLOOR PLAN
The SEDONA

DATE: 12/13/24
REVISION:
INFO:

ELECTRICAL LEGEND	
SYMBOL	DESCRIPTION
	110 OUTLET - DUPLEX
	110 OUTLET - GFI
	WEATHERPROOF GFI RECEPTACLE
	220 RECEPTACLE
	110 FLOOR OUTLET
	SINGLE LIGHT SWITCH
	CEILING MOUNTED FIXTURE
	WALL MOUNTED FIXTURE
	RECESSED FIXTURE
	EXHAUST FAN/LIGHT COMBO
	SMOKE DETECTOR
	CABLE OUTLET
	PHONE JACK
	GARAGE DOOR OPENER PRE-WIRE
	AUDIO WIRE HOOKUP
	SURROUND SOUND SPEAKER
	CEILING FAN

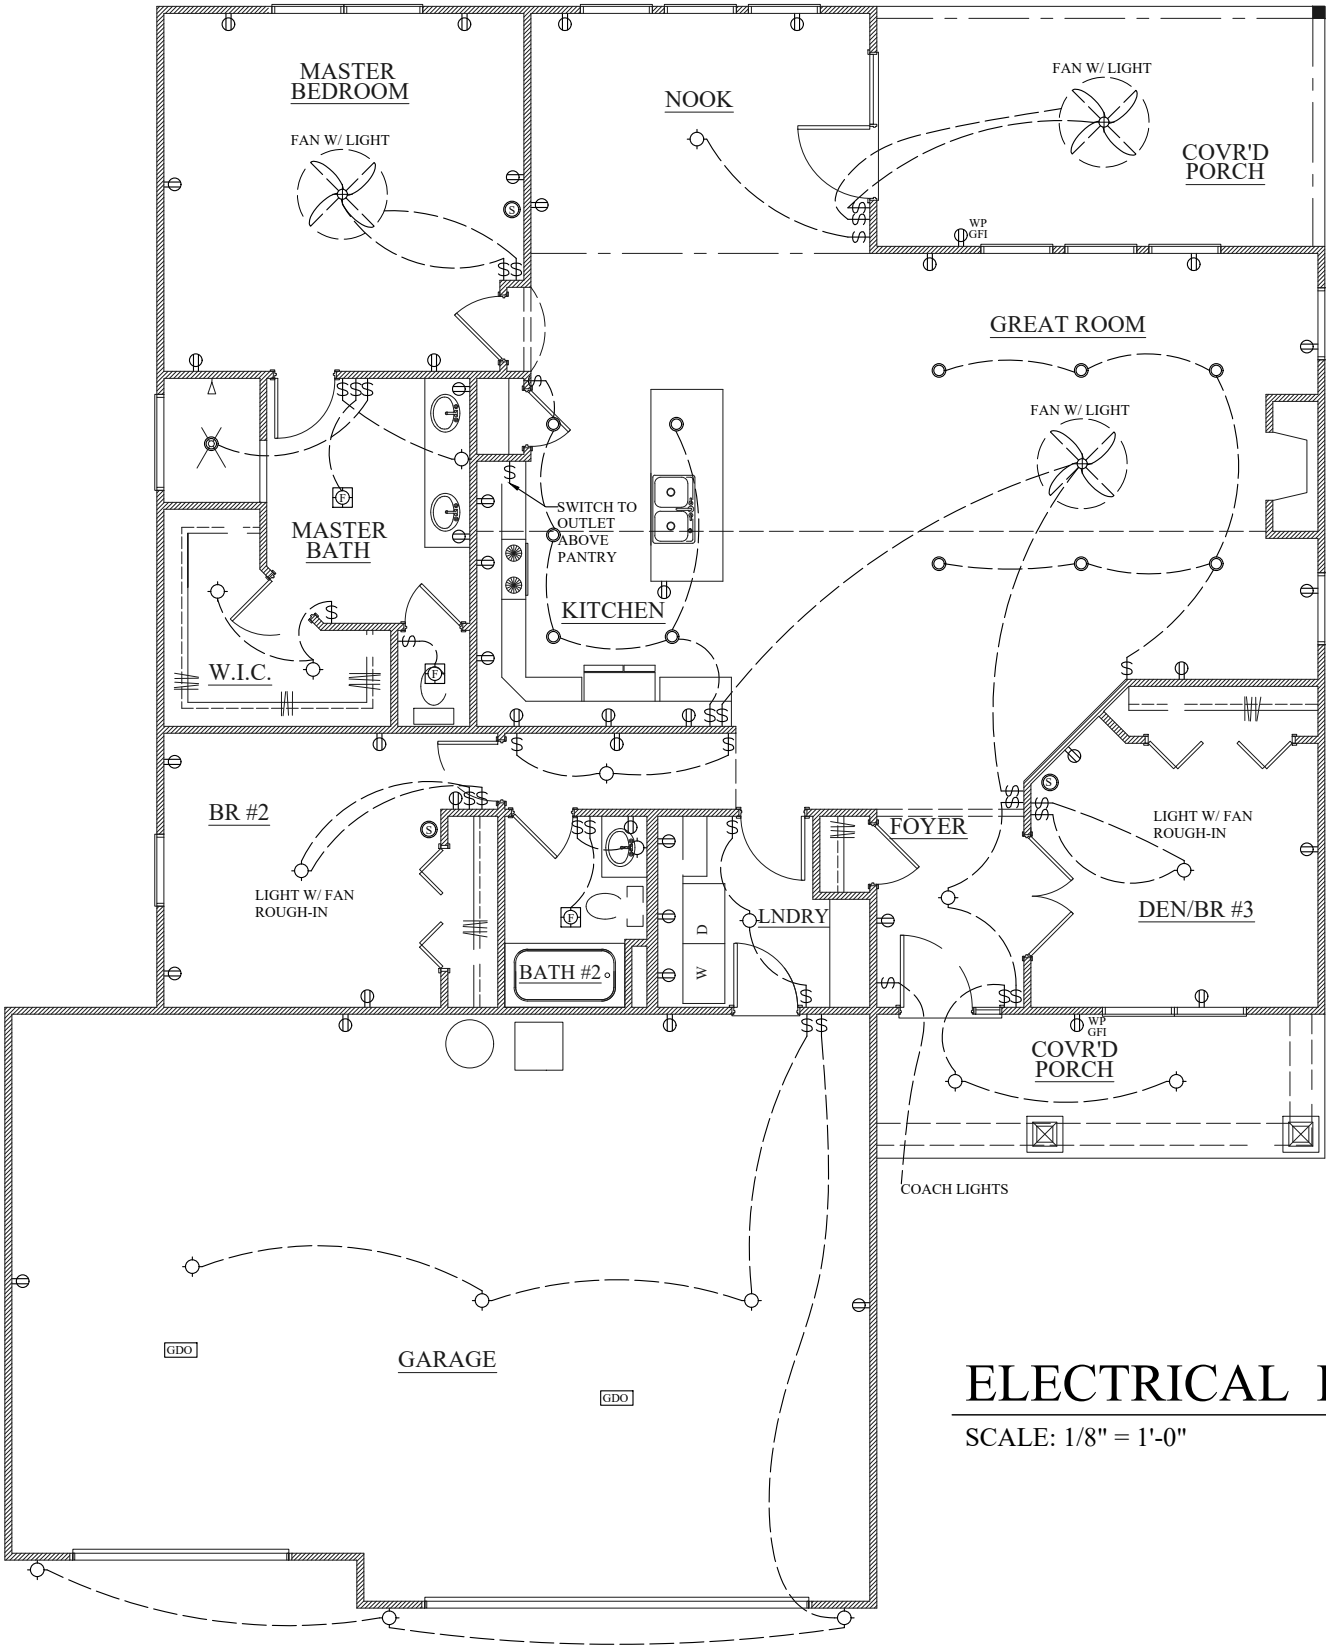

ELECTRICAL PLAN
SCALE: 1/8" = 1'-0"



765-491-7681

SQUARE FOOTAGE	
LIVING:	1857 SF
GARAGE:	817 SF

BLUEPRINT APPROVED

Milakis Rep: _____

Homeowner: _____

Date: _____

Any revisions made after blueprint approval will incur a minimum charge of \$300 in addition to the incurred cost of the physical changes to house.

ELECTRICAL PLAN
The SEDONA


DATE: 12/13/24
REVISION:
INFO:

- NOTES:
- 12" ROOF OVERHANG (UNLESS OTHERWISE NOTED.)
 - ALL WALLS TO BE 2x4 (UNLESS OTHERWISE NOTED.)
 - "SIMONTON" SINGLE-HUNG WINDOWS (UNLESS OTHERWISE NOTED.)



SQUARE FOOTAGE	
LIVING:	1857 SF
GARAGE:	871 SF

BLUEPRINT APPROVED	
Milakis Rep:	
Homeowner:	
Date:	
Any revisions made after blueprint approval will incur a minimum charge of \$300 in addition to the incurred cost of the physical changes to house.	

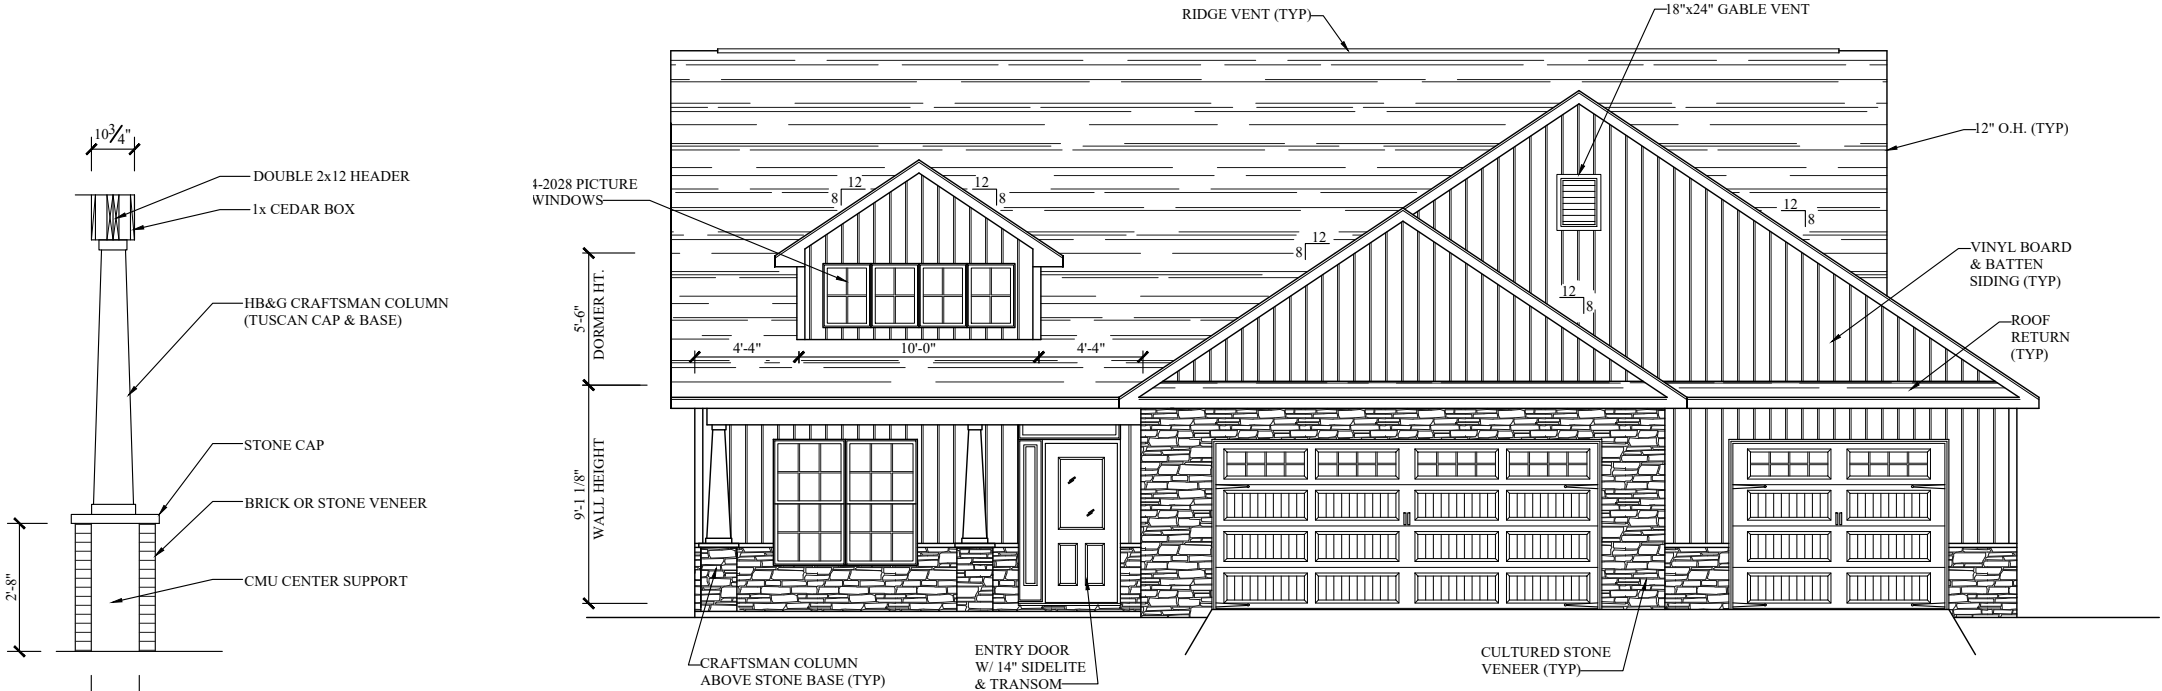


FRONT ELEVATION

SCALE: 1/8" = 1'-0"


PORCH COLUMN & HEADER SECTION

SCALE: 1/4" = 1'-0"

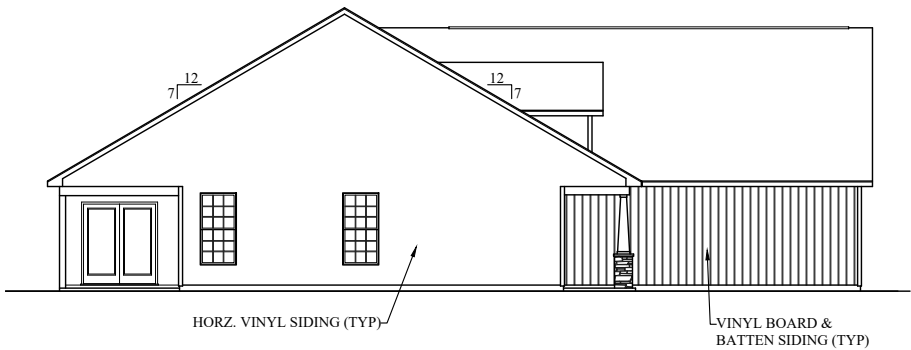


LEFT ELEVATION

SCALE: 1/16" = 1'-0"

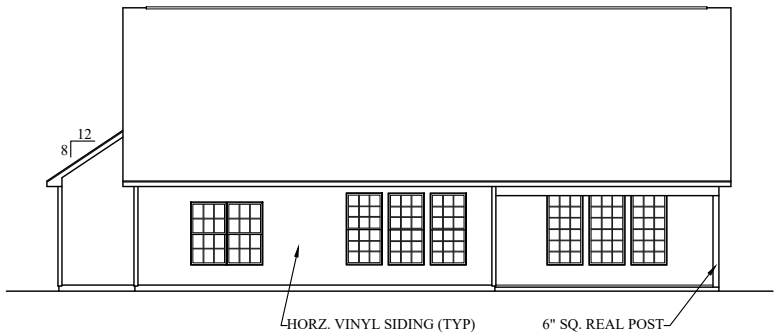

REAR ELEVATION

SCALE: 1/16" = 1'-0"

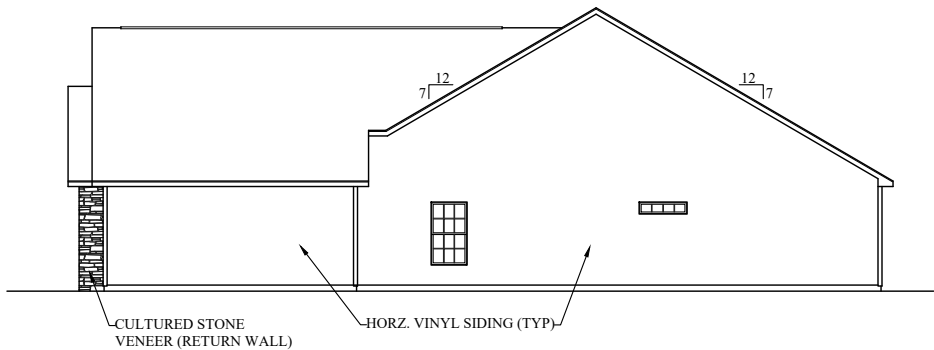


RIGHT ELEVATION

SCALE: 1/16" = 1'-0"


ELEVATIONS The SEDONA

DATE: 12/13/24
REVISION:
INFO:

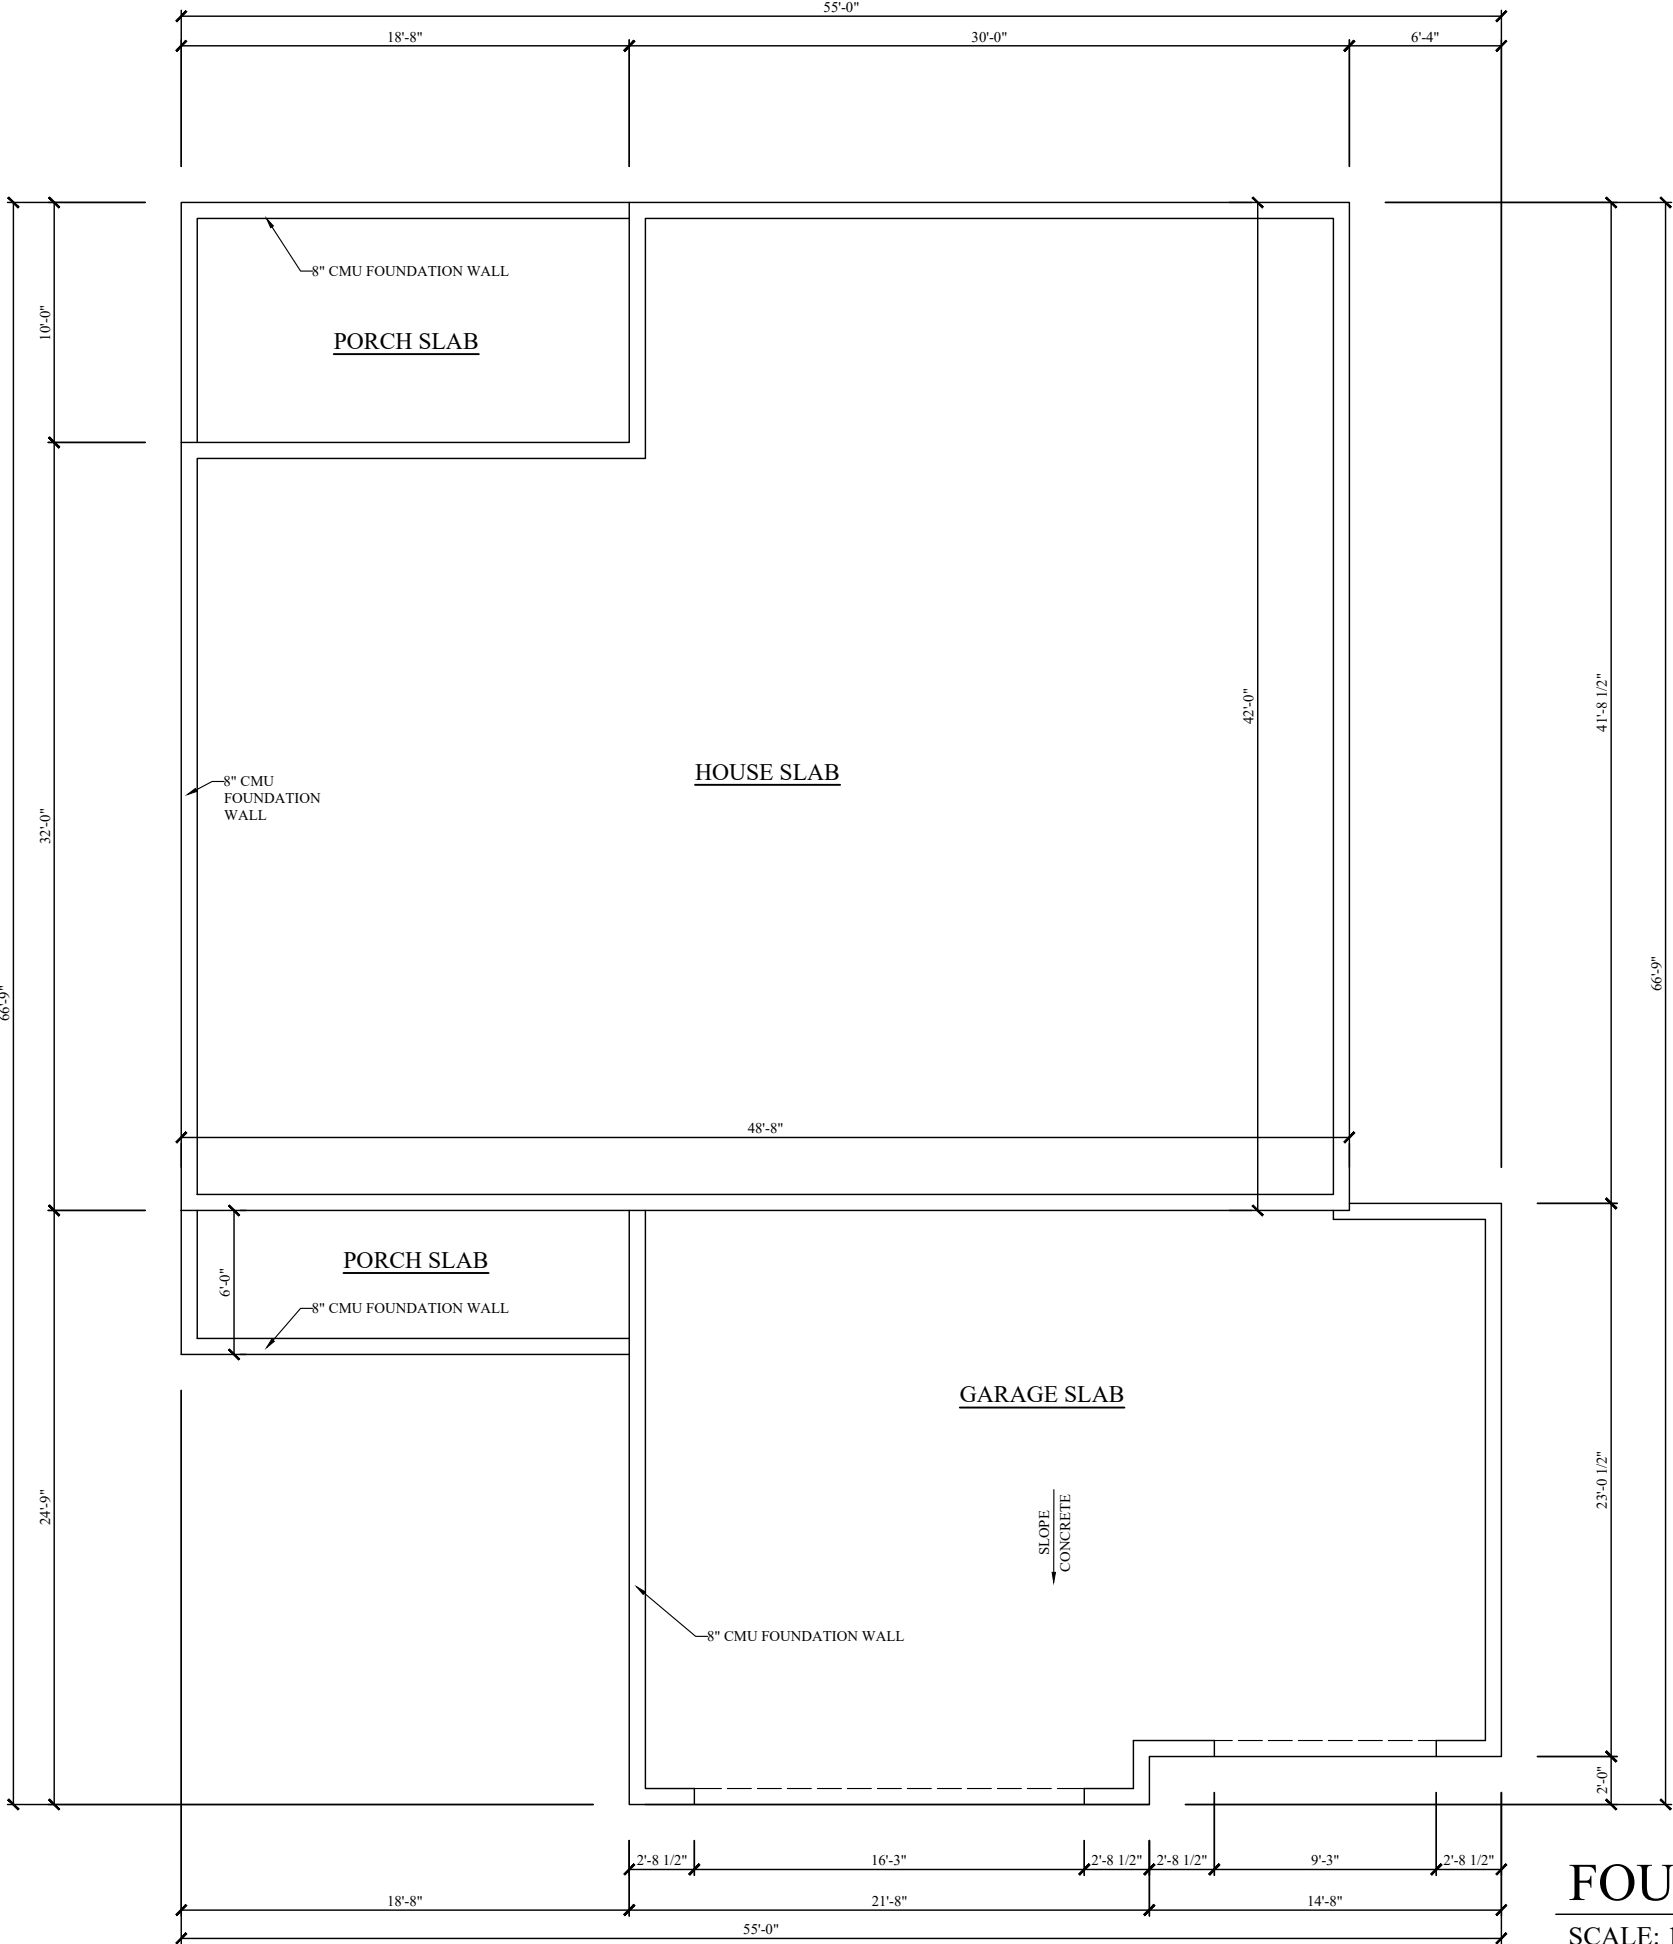

FOUNDATION PLAN

SCALE: 1/8" = 1'-0"

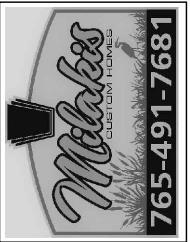


SQUARE FOOTAGE	
LIVING:	1857 SF
GARAGE:	871 SF

BLUEPRINT APPROVED	
Milakis Rep:	_____
Homeowner:	_____
Date:	_____
Any revisions made after blueprint approval will incur a minimum charge of \$300 in addition to the incurred cost of the physical changes to house.	

FOUNDATION PLAN

The SEDONA

DATE: 12/13/24
REVISION:
INFO:

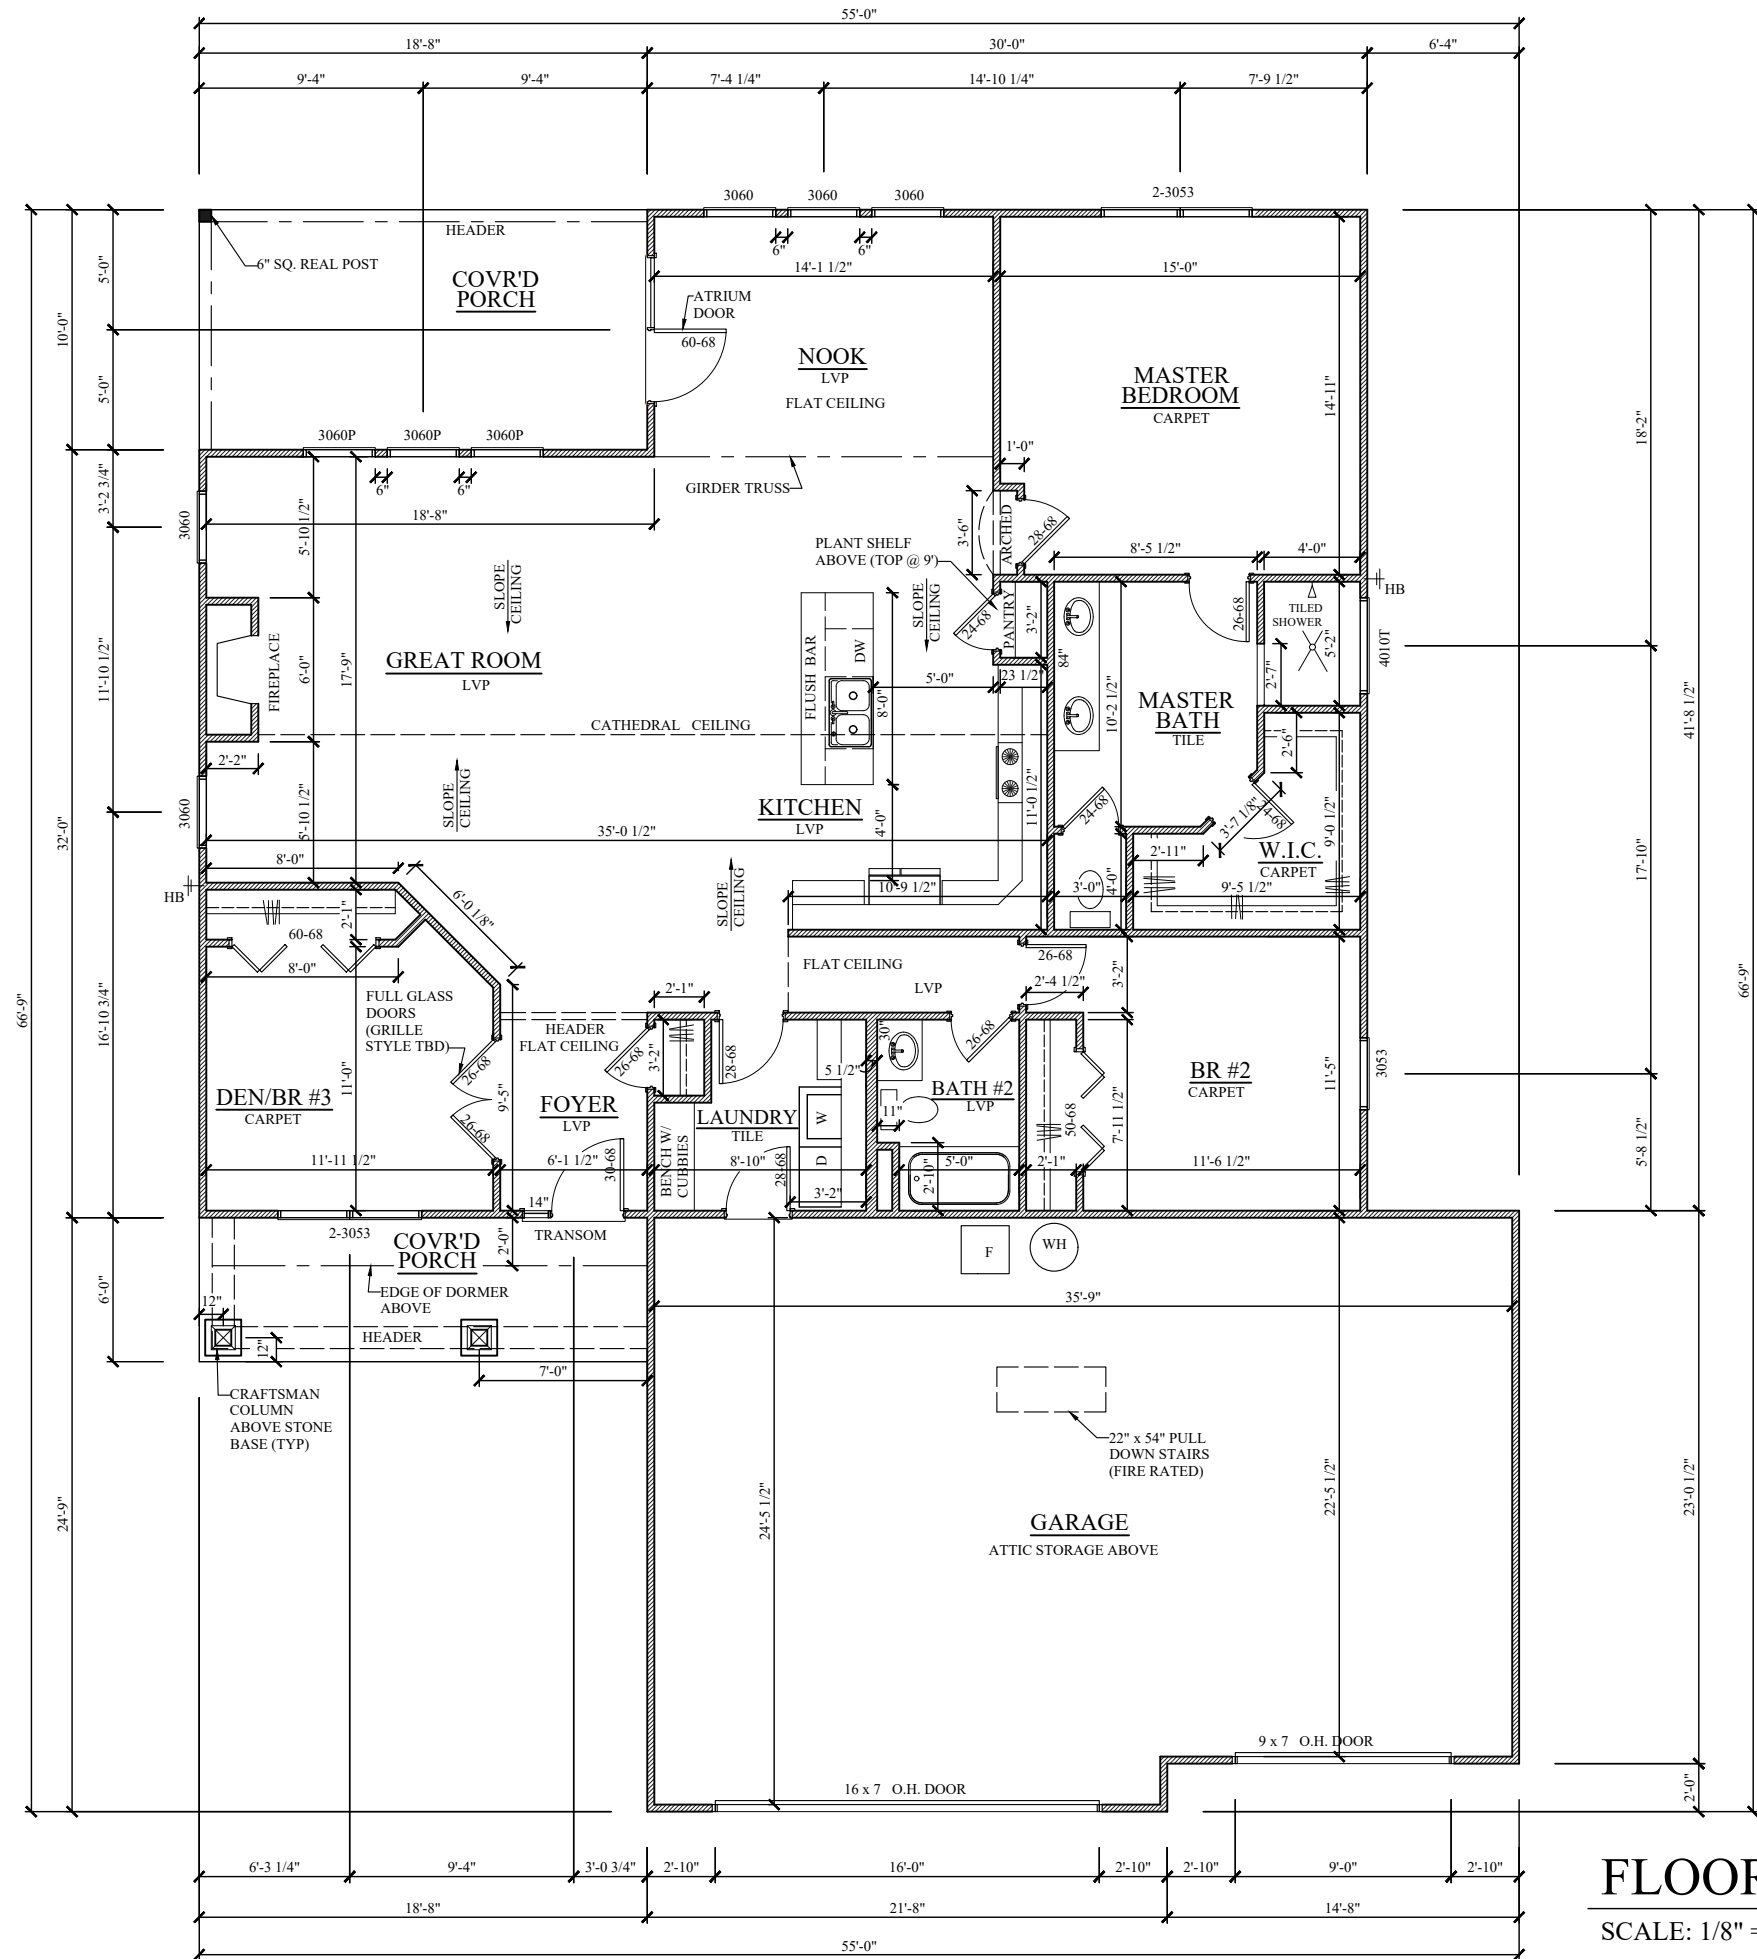

FLOOR PLAN
SCALE: 1/8" = 1'-0"




SQUARE FOOTAGE	
LIVING:	1857 SF
GARAGE:	871 SF

BLUEPRINT APPROVED	
Milakis Rep:	
Homeowner:	
Date:	
Any revisions made after blueprint approval will incur a minimum charge of \$300 in addition to the incurred cost of the physical changes to house.	

FLOOR PLAN
The SEDONA

DATE: 12/13/24
REVISION:
INFO:

ELECTRICAL LEGEND	
	110 OUTLET - DUPLEX
	110 OUTLET - GFI
	WEATHERPROOF GFI RECEPTACLE
	220 RECEPTACLE
	110 FLOOR OUTLET
	SINGLE LIGHT SWITCH
	CEILING MOUNTED FIXTURE
	WALL MOUNTED FIXTURE
	RECESSED FIXTURE
	EXHAUST FAN/LIGHT COMBO
	SMOKE DETECTOR
	CABLE OUTLET
	PHONE JACK
	GARAGE DOOR OPENER PRE-WIRE
	AUDIO WIRE HOOKUP
	SURROUND SOUND SPEAKER
	CEILING FAN

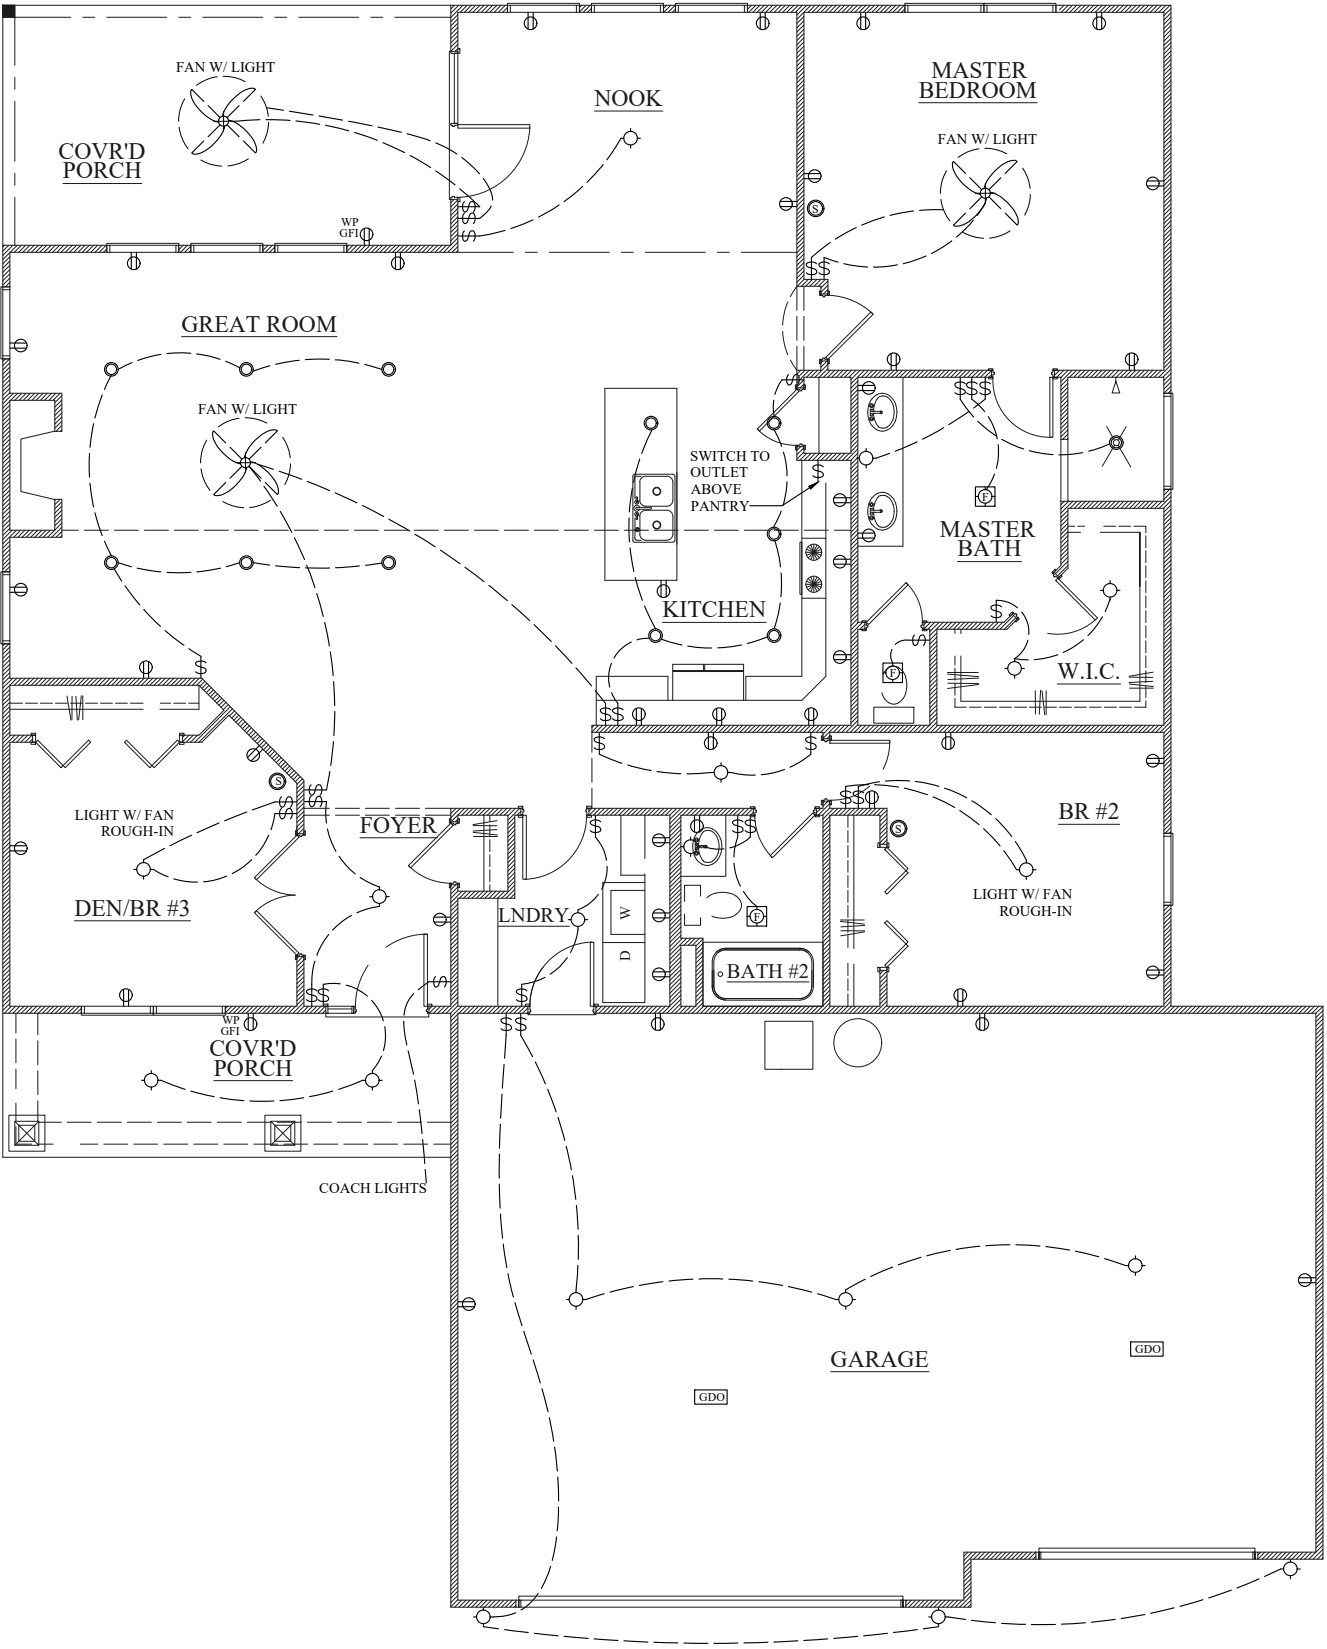

ELECTRICAL PLAN

SCALE: 1/8" = 1'-0"



SQUARE FOOTAGE	
LIVING:	1857 SF
GARAGE:	871 SF

BLUEPRINT APPROVED	
Milakis Rep:	_____
Homeowner:	_____
Date:	_____
Any revisions made after blueprint approval will incur a minimum charge of \$300 in addition to the incurred cost of the physical changes to house.	

ELECTRICAL PLAN
The SEDONA

DATE: 12/13/24
REVISION:
INFO: